


3191 DANVILLE BLVD.
ALAMO, CA

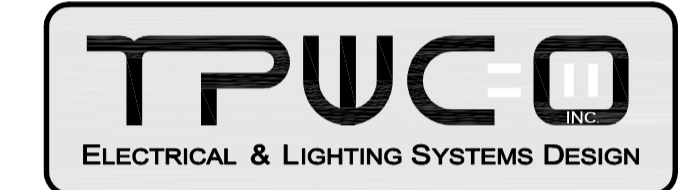

3346 Barnmouth Drive - Antioch, CA 94509
Tel: (925) 754-9927 Fax: (925) 754-9376
Email: design@tpwco.com

2	AS-BUILT RECORD SET	06/26/2008
1	ISSUED FOR PERMIT	06/14/2007

Issue	Description	Date
-------	-------------	------

IA INTERIOR ARCHITECTS

LOS ANGELES



550 SOUTH HOPE STREET, SUITE 1700
LOS ANGELES, CALIFORNIA 90071
TEL 213-623-2164 FAX 213-623-2139

© 2007 INTERIOR ARCHITECTS, INC., A CALIFORNIA CORPORATION. ALL DRAWINGS AND WRITTEN MATERIAL HEREIN CONSTITUTE THE ORIGINAL AND UNPUBLISHED WORK OF THE ARCHITECT, AND THE SAME MAY NOT BE DUPLICATED, USED, OR DISCLOSED WITHOUT THE WRITTEN CONSENT OF THE ARCHITECT.

Drawn: DB Check: TW Owner Approval:

Job No. 0727500 Scale: AS NOTED

LIGHTING PLAN
E-3.1

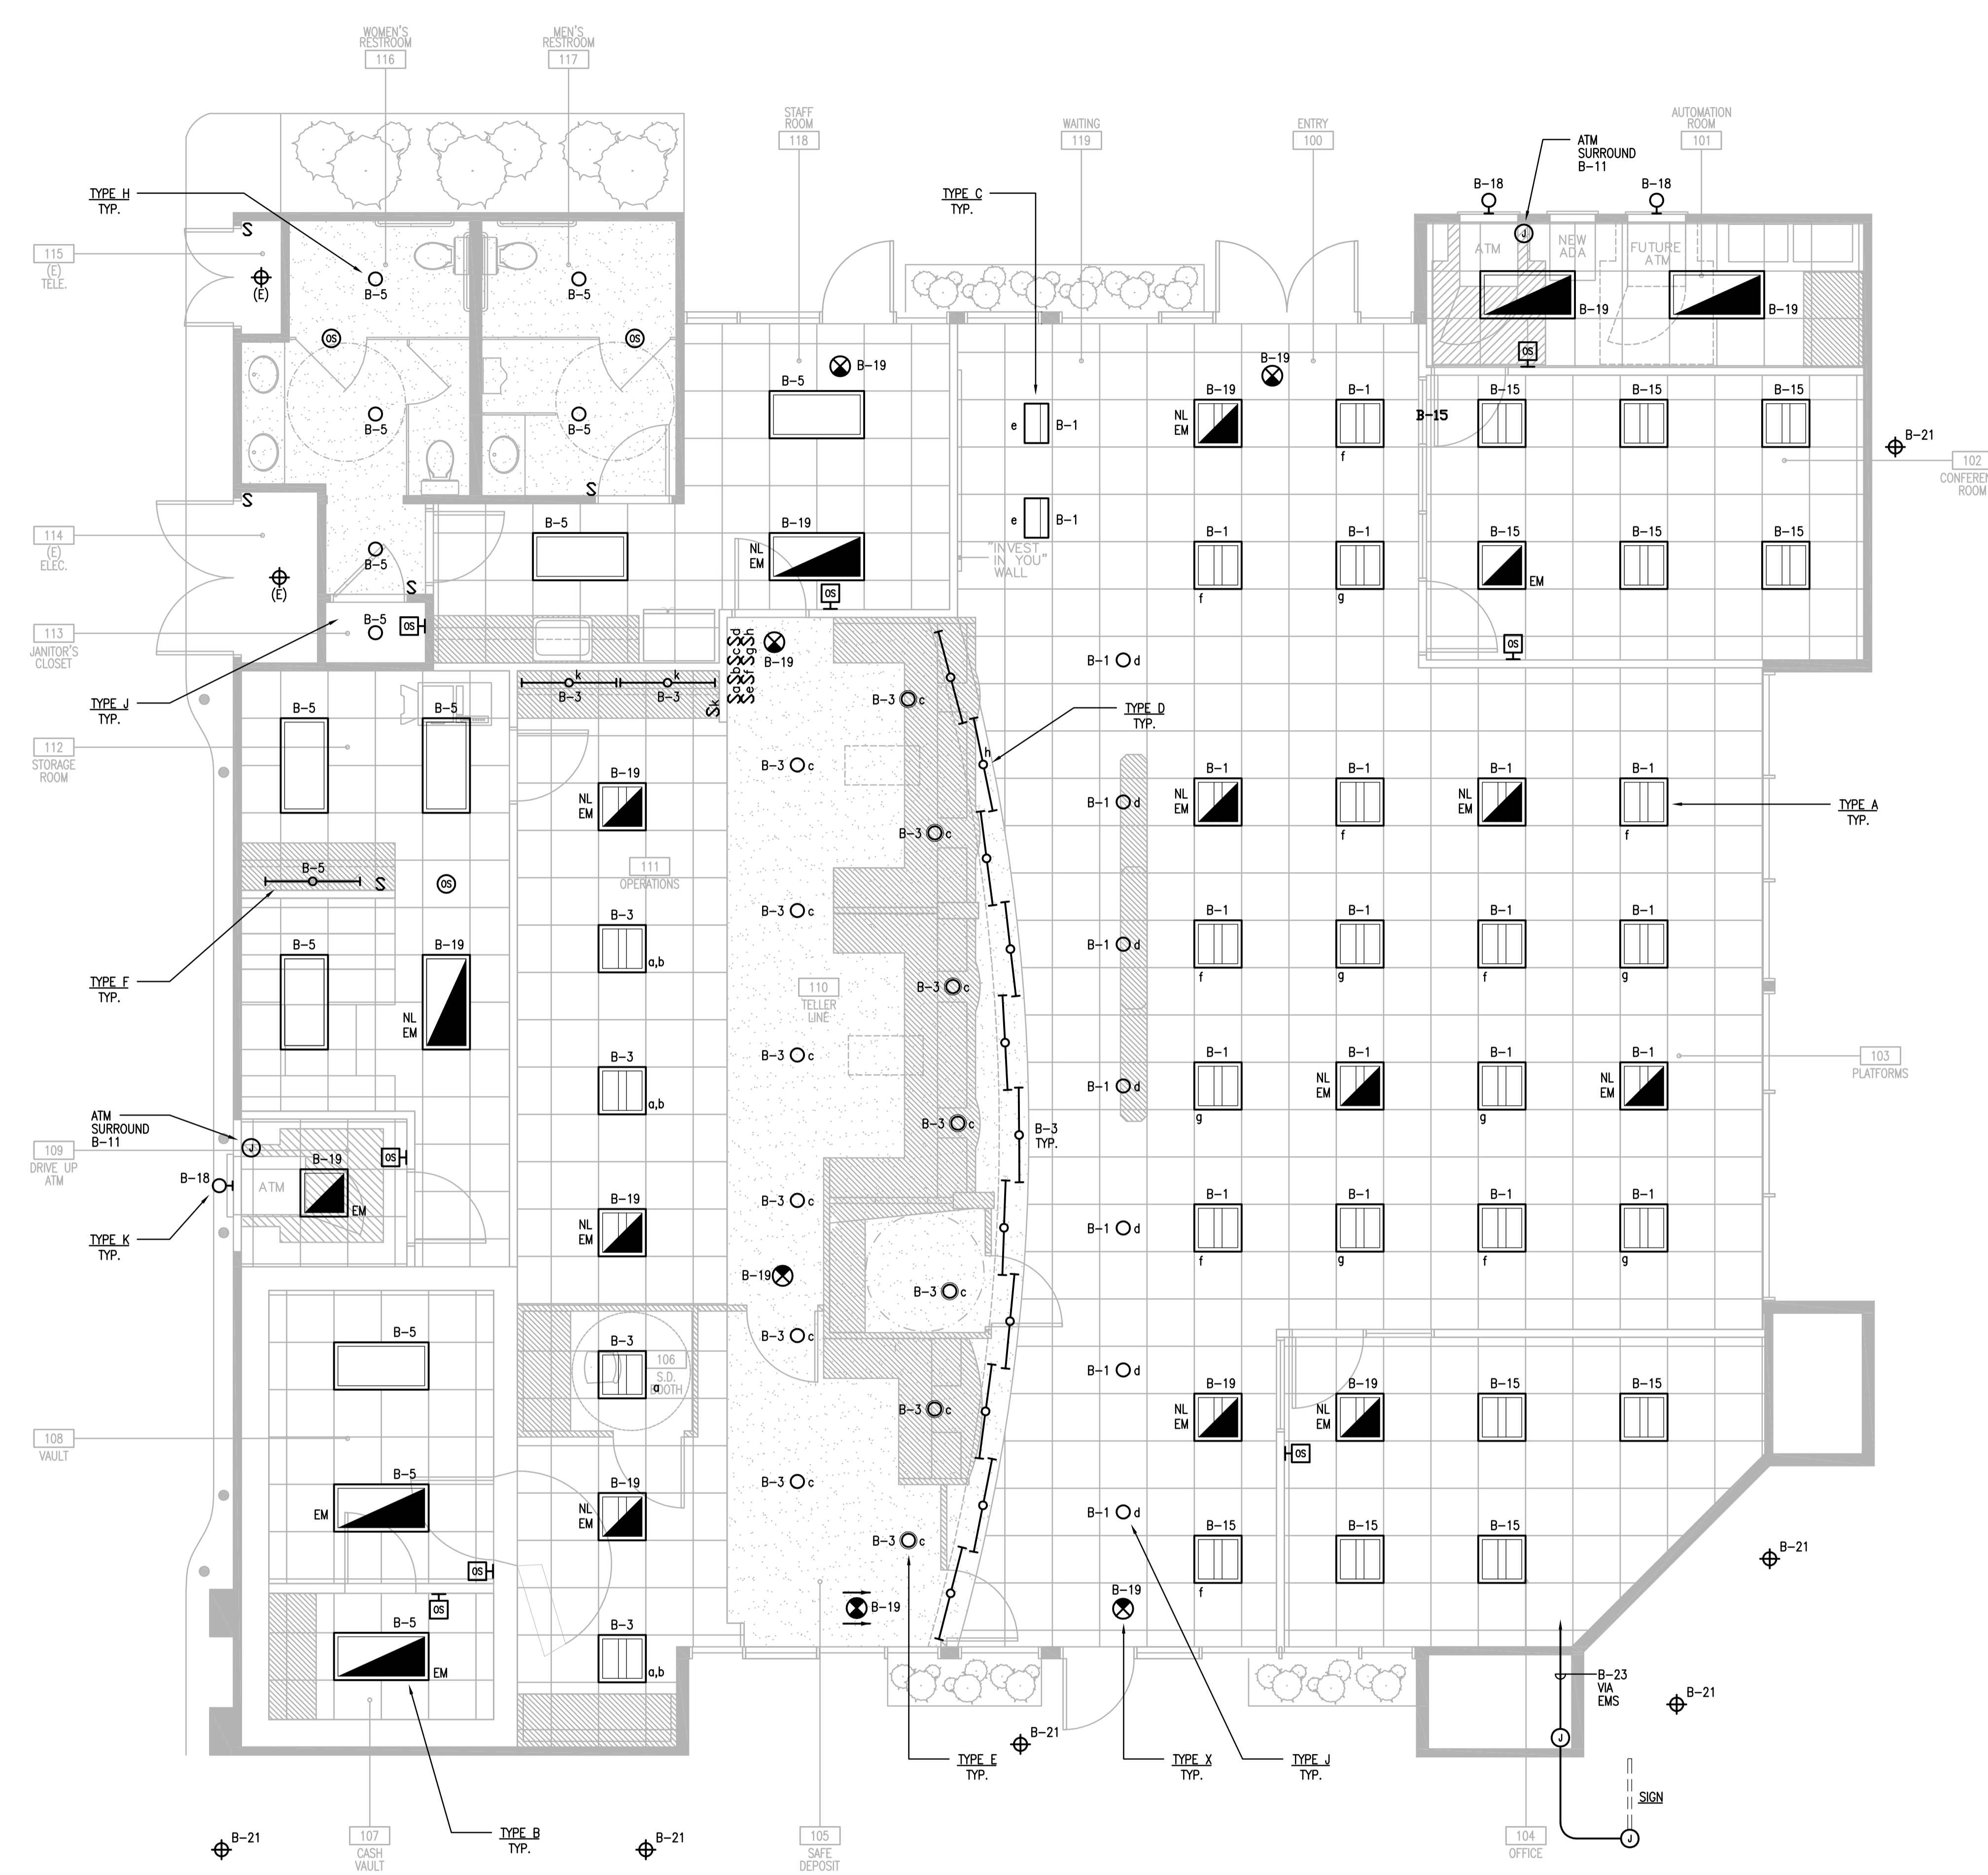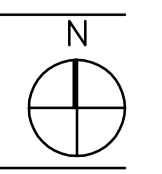

1 LIGHTING PLAN
SCALE: 1/4" = 1'-0"