


NO.	DESCRIPTION	DATE
1	BID/PERMIT	06.10.08
ADDENDUM 01/		08.20.08
	PLAN CHECK REV.	
BULLETIN 004		12.15.08
	PLAN CHECK REV.	03.23.09
2	AS-BUILTS	04.10.09

SHEET TITLE:

FIRST FLOOR  
LIGHTING PLAN

PROJECT NO.:	0807.10
DRAWN BY:	DB
CHECKED BY:	TW
SCALE:	AS NOTED
CAD FILE:	Elan
SHEET NO.:	

E6.0

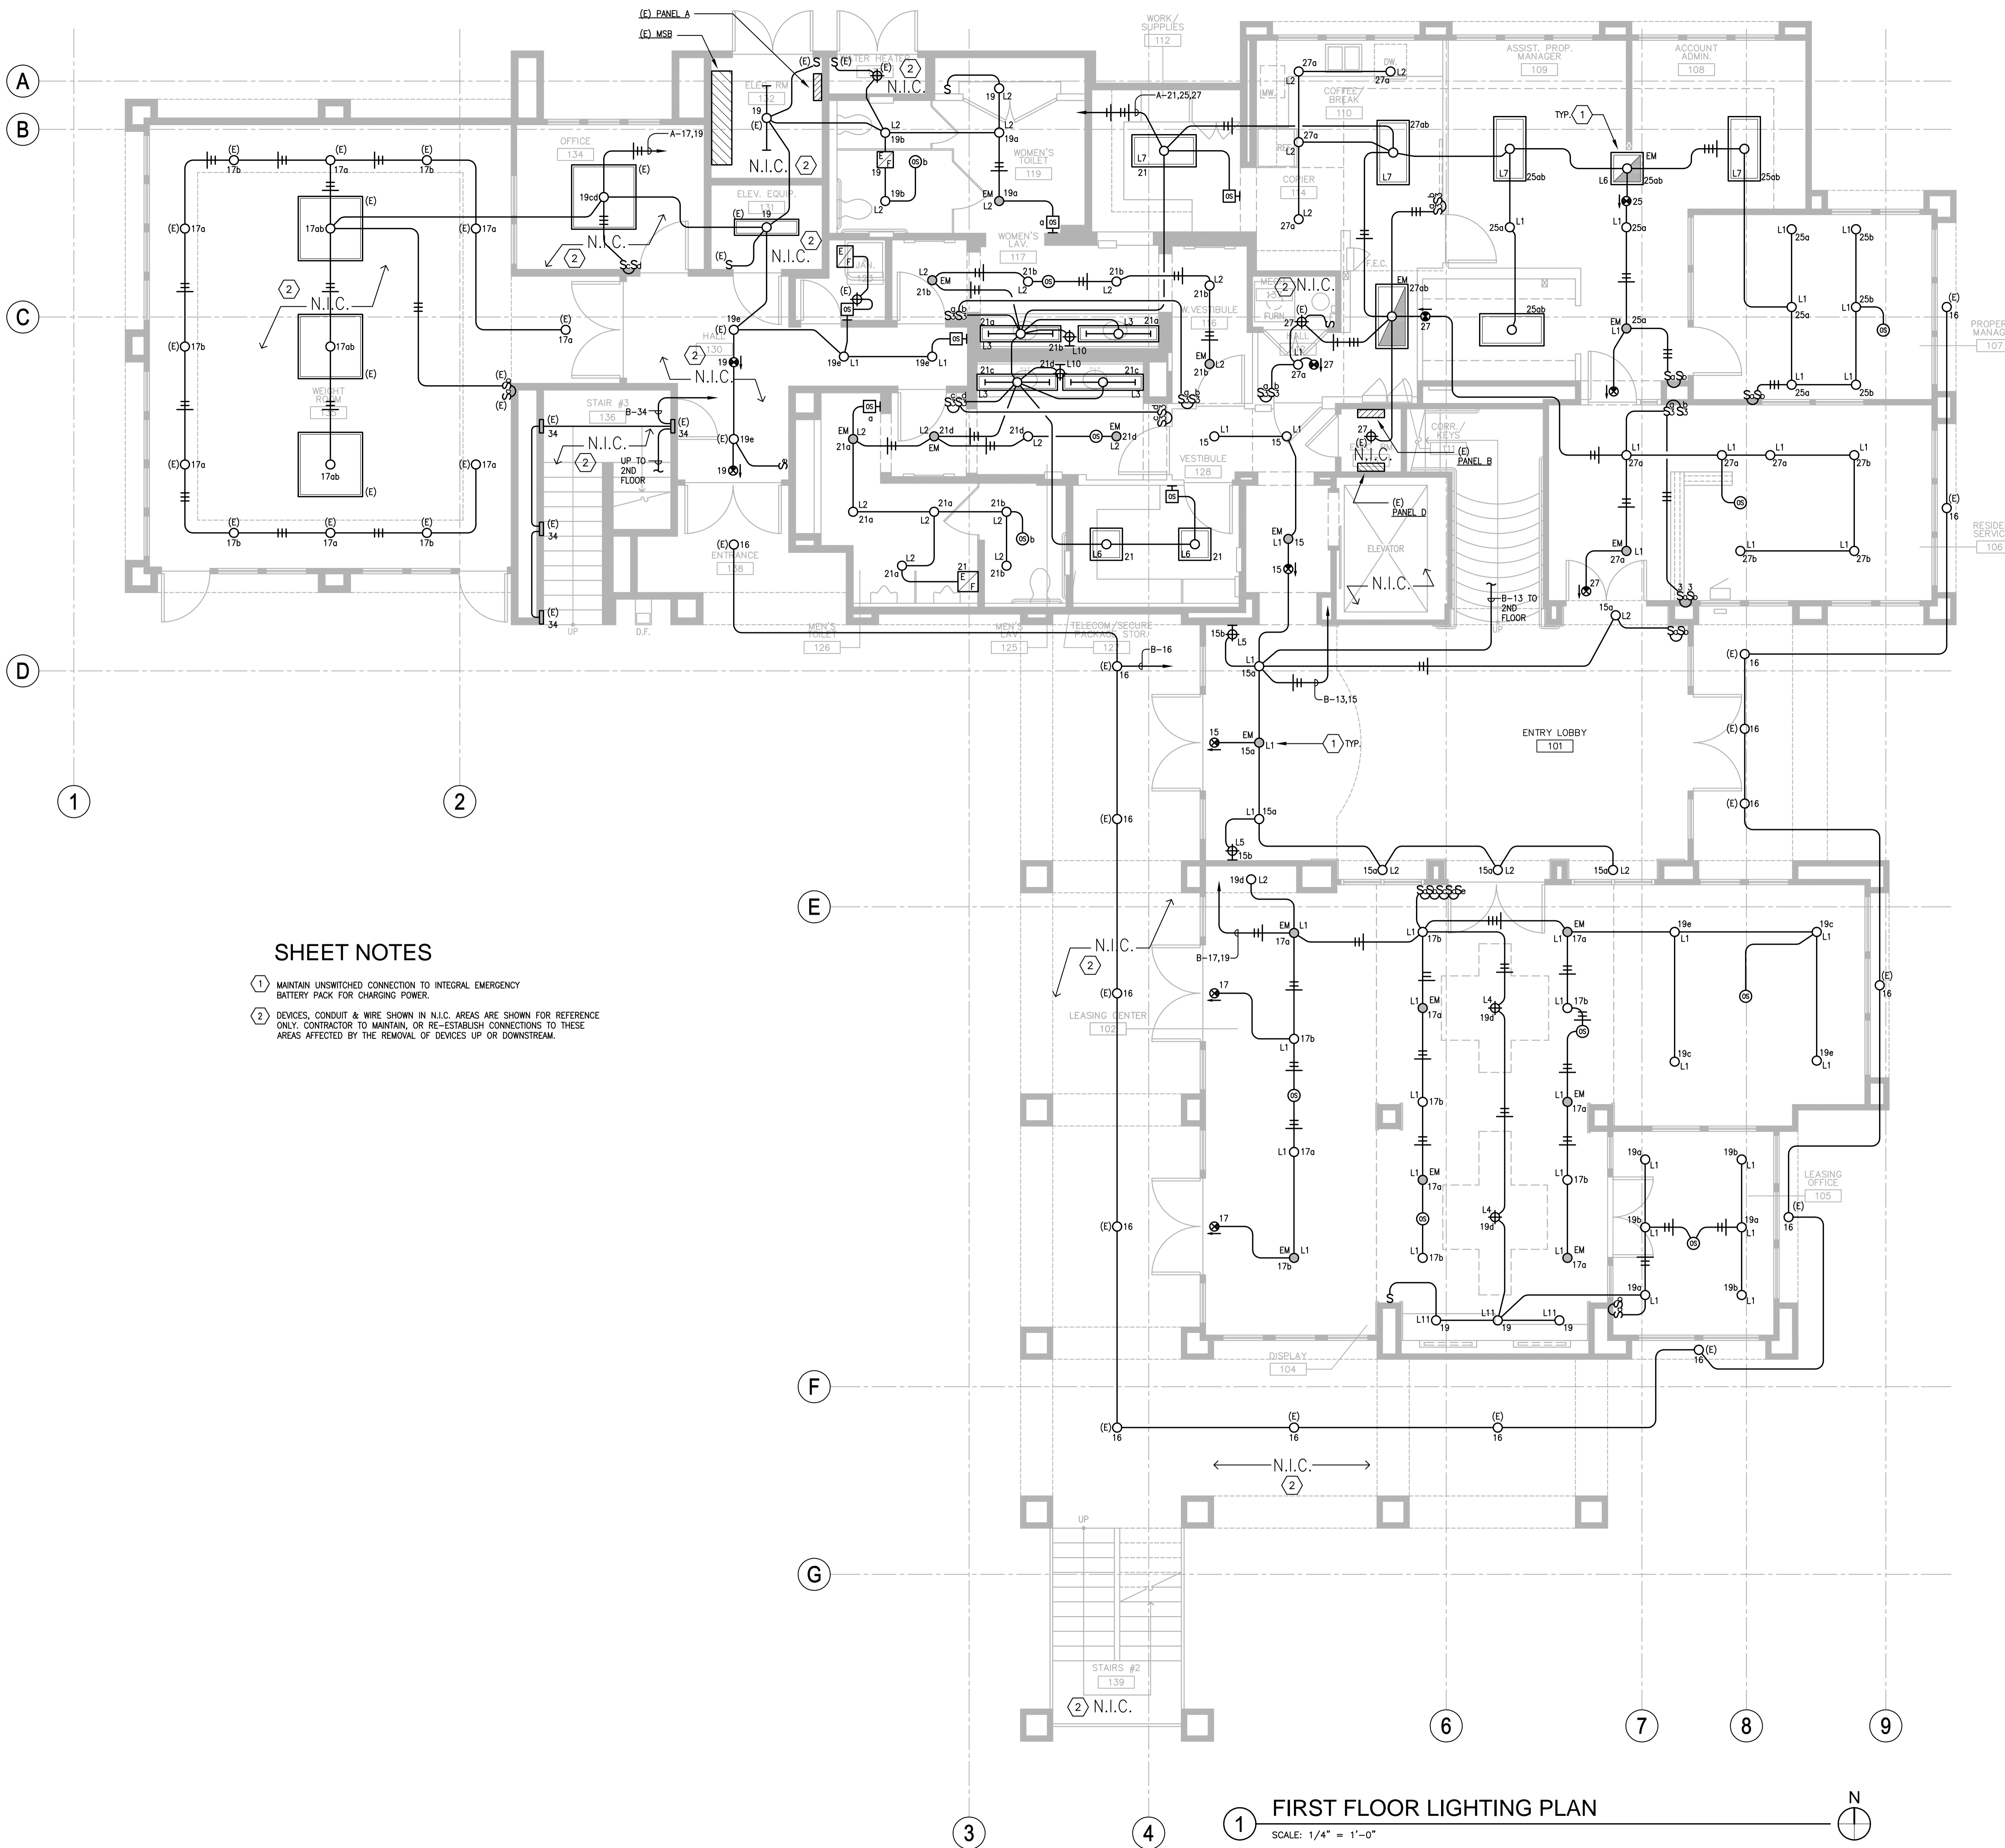

SHEET NOTES

- 1 MAINTAIN UNSWITCHED CONNECTION TO INTEGRAL EMERGENCY BATTERY PACK FOR CHARGING POWER.
- 2 DEVICES, CONDUIT & WIRE SHOWN IN N.I.C. ARE SHOWN FOR REFERENCE ONLY. CONTRACTOR TO MAINTAIN, OR RE-ESTABLISH CONNECTIONS TO THESE AREAS AFFECTED BY THE REMOVAL OF DEVICES UP OR DOWNSTREAM.

1 FIRST FLOOR LIGHTING PLAN  
SCALE: 1/4" = 1'-0"

