

STAMP:

REVISIONS

NO.	DESCRIPTION	DATE
1	75% PROGRESS SET	07.24.09
2	100% REVIEW SET	08.05.09

PROJECT:

Site Lighting Upgrade



Kennedy Park

1333 Decoto Road
Union City, California 94587

SHEET:

Site Lighting Plan


DATE: 05.08.09

SCALE: AS NOTED

JOB NO.: 0904.10

SHEET NO.:

SL1.0

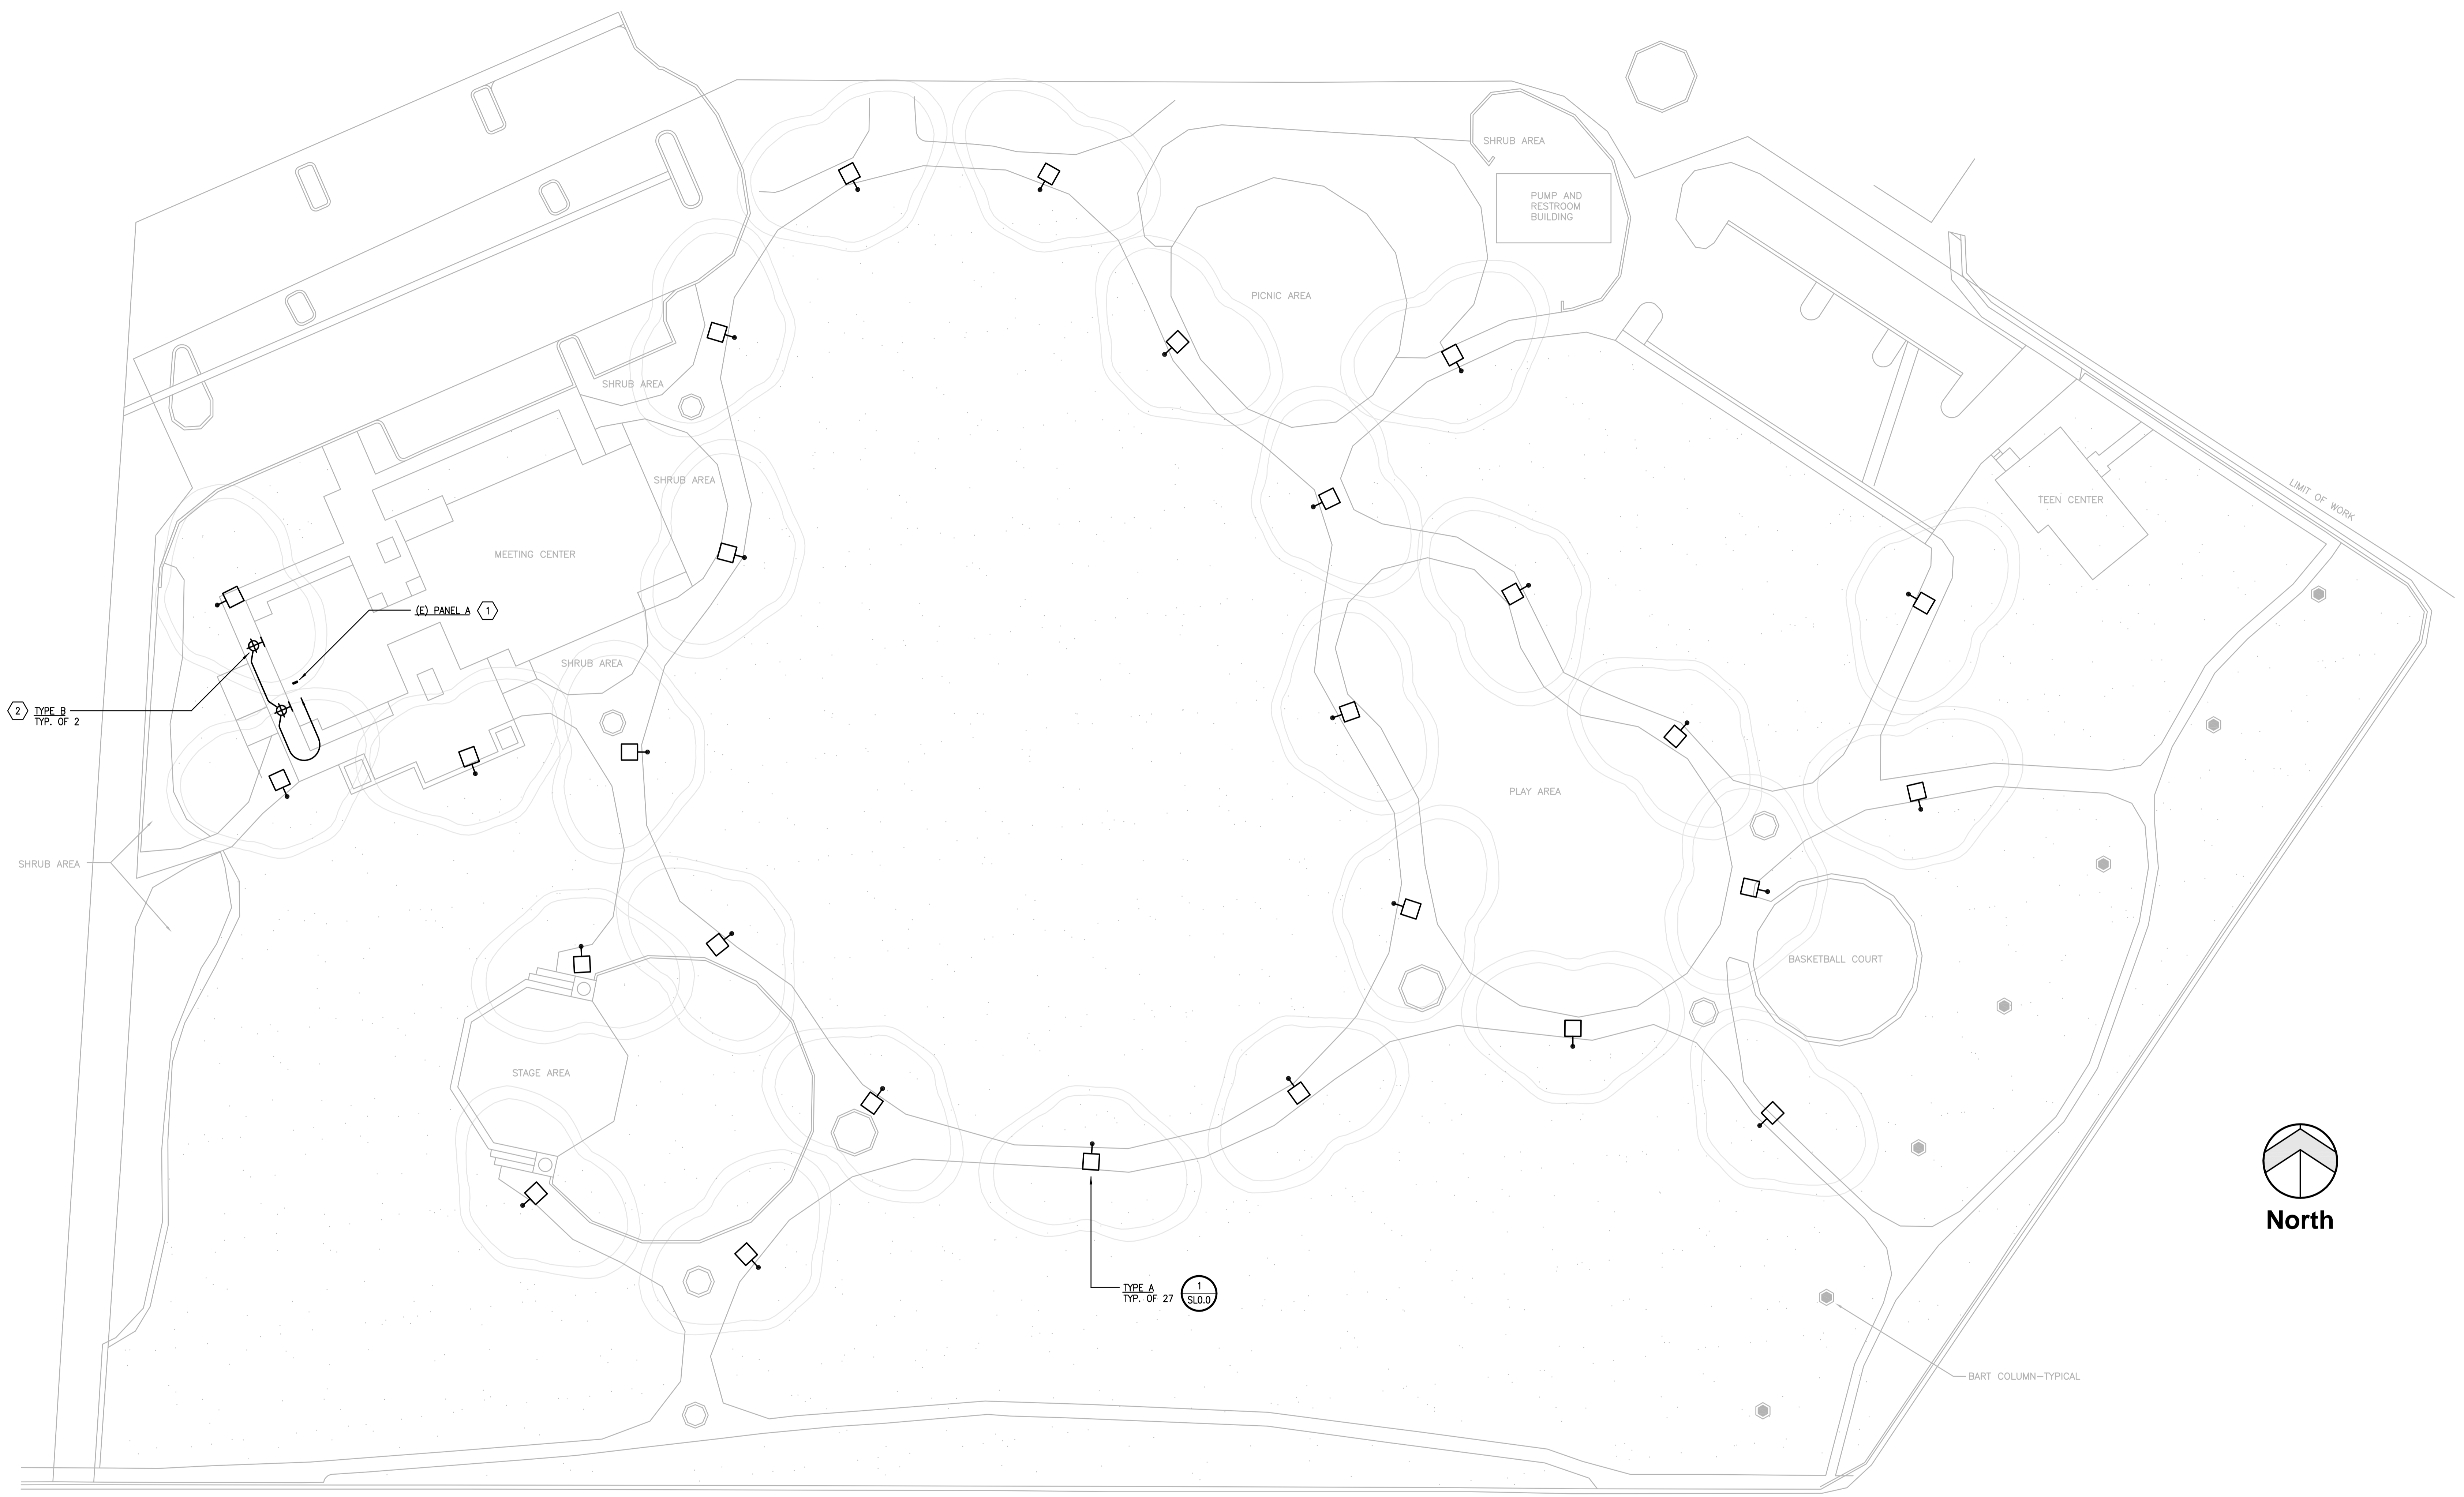

1 Site Lighting Plan
Scale: 1" = 30'-0"

Sheet Notes

- ① EXISTING PANEL A: UTILIZE (E) SPARE BREAKER & CIRCUIT NEW TYPE B WALL MOUNTED FIXTURES VIA (E) SITE LIGHTING TIME CLOCK.
- ② LOCATE TYPE B FIXTURES, WALL MOUNTED, CENTERED ABOVE EACH EXIT DOOR.