


1 Site Plan
SCALE: 1" = 20'-0"

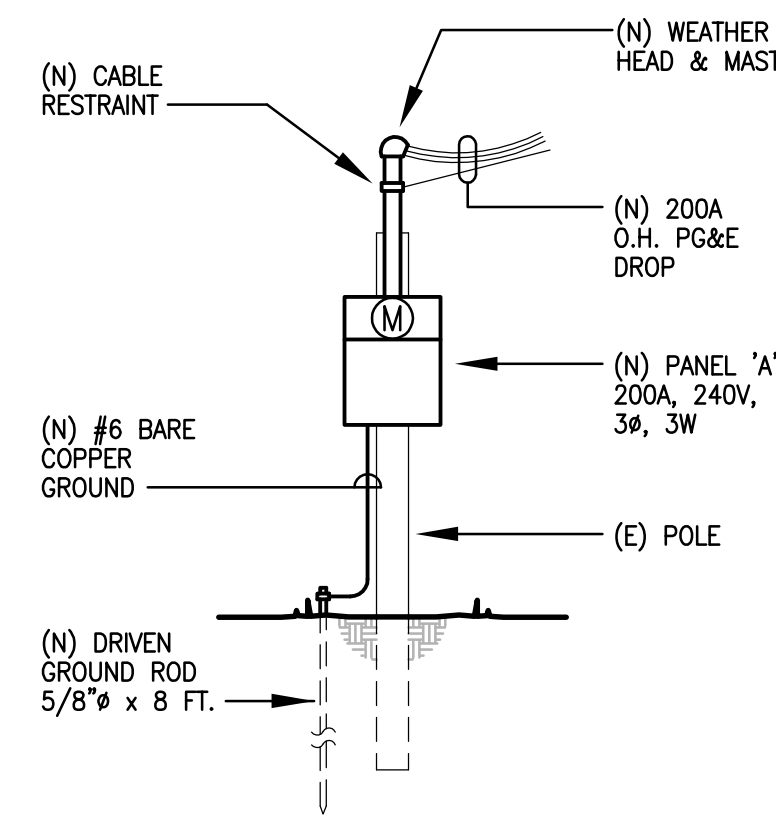

2 New Service Drop & Panel 'A'
SCALE: NTS

General Notes

- ALL CONDUCTORS TO BE COPPER UNLESS OTHERWISE NOTED.
- NOTIFY THE DESIGNER & OWNER IMMEDIATELY UPON THE DISCOVERY OF ANY ITEM OR CONDITION THAT REQUIRES MODIFICATION TO THE LAYOUT OR CONNECTIONS OF DEVICES OR EQUIPMENT INDICATED ON THESE PLANS, PRIOR TO THEIR INSTALLATION.
- ALL ELECTRICAL EQUIPMENT OR DEVICES MOUNTED ON THE ROOF OR EXTERIOR TO THE BUILDING, SHALL BE SUITABLE FOR EXTERIOR USE IN DAMP OR WET LOCATIONS & LABELLED ACCORDINGLY.
- FIRE ALARM SYSTEM SHALL BE DESIGNED, PROVIDED & INSTALLED BY OTHERS.
- SEAL ALL ROOF PENETRATIONS WITH APPROVED MATERIALS.
- COORDINATE EXACT LOCATIONS OF ALL MECHANICAL EQUIPMENT WITH MECHANICAL DRAWINGS.
- ALL CIRCUITS SHOWN CONNECTED TO BRANCH PANELS MUST ALSO CONTAIN A CODE REQUIRED GROUNDING CONDUCTOR.
- ALL ELECTRICAL CONNECTIONS SHALL BE MADE IN ACCORDANCE WITH THE FOLLOWING CODES:
 - * 2007 CALIFORNIA BUILDING CODE
 - * 2007 CALIFORNIA MECHANICAL CODE
 - * 2007 CALIFORNIA ENERGY CODE
 - * 2006 NATIONAL ELECTRICAL CODE
 - * 2006 INTERNATIONAL BUILDING CODE
 - * 2007 CALIFORNIA ELECTRICAL CODE
 - * ADA SECTION III (TITLE 24)
 - * CITY OF LAGUNA NIGUEL CODES & ORDINANCES
- COORDINATE EXACT NEMA RECEPTACLE AND / OR PLUG REQUIREMENTS WITH INDIVIDUAL EQUIPMENT SUPPLIER / VENDOR, PRIOR TO INSTALLATION.
- ALL GENERAL USE RECEPTACLES NOT SPECIFICALLY DEDICATED FOR USE BY DESIGNATED EQUIPMENT, SHALL BE INSTALLED AT A MINIMUM HEIGHT OF 15 INCHES ABOVE FINISHED FLOOR TO CENTER OF DEVICE.
- ALL WIRING SHALL BE INSTALLED IN APPROVED RACEWAYS.
- ALL NON-PORTABLE EQUIPMENT SHALL BE HARD WIRED.
- THE APPROVAL OF ALL ELECTRICAL WORK IS SUBJECT TO FIELD INSPECTIONS.
- ALTHOUGH NOT SHOWN FOR CLARITY, ALL RACEWAYS & HOMERUNS CONTAIN #12 AWG, UNLESS OTHERWISE NOTED ON PLANS.

Sheet Notes

- NEW PANEL 'A': 200A, 240V, 3ø, 3W. SEE PANEL SCHEDULE ON SHEET E2.0.
- NEW 200A OVERHEAD PG&E DROP; COORDINATE EXACT REQUIREMENTS WITH PG&E SERVICE REPRESENTATIVE.

Drawing Index

- E1.0 SITE PLAN, SYMBOLS & NOTES
- E2.0 POWER & SIGNAL PLAN
- E3.0 LIGHTING PLAN
- E4.0 TITLE 24 FORMS

Symbols Legend

	PENDANT MOUNTED FIXTURE
	WALL MOUNTED FIXTURE
	SURFACE MOUNTED FLUORESCENT FIXTURE
	EMERGENCY WALL PACK
	LED EXIT SIGN; WITH EMERGENCY HEADS WHERE SHOWN
	OCCUPANCY SENSOR; WALL OR CEILING MOUNTED
	SINGLE POLE TOGGLE SWITCH; SUBSCRIPT DENOTES FIXTURE OR LAMPS CONTROLLED
	THREE-WAY TOGGLE SWITCH. SUBSCRIPT DENOTES FIXTURE OR LAMPS CONTROLLED
	MOTOR RATED SWITCH WITH THERMAL OVERLOAD PROTECTION
	TIMER SWITCH
	JUNCTION BOX; ABOVE CEILING OR SURFACE ON FLOOR
	JUNCTION BOX; WALL MOUNTED
	DUPLEX RECEPTACLE, WALL MOUNTED
	DOUBLE DUPLEX RECEPTACLE, WALL MOUNTED
	DUPLEX RECEPTACLE, MOUNTED AT HEIGHT AS INDICATED
	DOUBLE DUPLEX RECEPTACLE, MOUNTED AT HEIGHT AS INDICATED
	SPECIAL RECEPTACLE, COORDINATE EXACT NEMA PATTERN WITH EQUIPMENT
	POWER BOX; FLUSH MOUNTED IN FLOOR
	POWER/TELE/DATA BOX; FLUSH MOUNTED IN FLOOR
	TELEPHONE/DATA OUTLET
	MOTOR
	PANEL OR EQUIPMENT CABINET
	CABLE TV OUTLET
	FUSED DISCONNECT OR SWITCH
	DISCONNECT SWITCH TAG: 50AF/60AS/3PH/208V
	VOLTAGE
	PHASE
	SWITCH SIZE IN AMPS
	FUSE SIZE IN AMPS
	HOMERUN TO PANEL
	CONDUIT RACEWAY
	PHASE CONDUCTOR
	NEUTRAL CONDUCTOR
	CONDUIT UP OR DOWN
	FLEXIBLE CONDUIT
	NUMBERED NOTE TAG
	FEEDER TAG
	FIXTURE TYPE DESIGNATION
	MECHANICAL EQUIPMENT DESIGNATION
	PANEL & CIRCUIT DESIGNATION
A-1,3,5	AMPS
A	AIR CONDITIONER
A/C	AIR CONDITIONER
AFF	ABOVE FINISHED FLOOR
AFI	ARC FAULT INTERRUPTER
AL	ALUMINUM
C	CONDUIT
CATV	CABLE TELEVISION
CB	CIRCUIT BREAKER
COM.	COMMERCIAL
DISP.	GARBAGE DISPOSER
(E)	EXISTING
F	FAN
FAU	FORCED AIR UNIT
GFI	GROUND FAULT INTERRUPTER
ELEC.	ELECTRICAL
GRD.	GROUND
MCB	MAIN CIRCUIT BREAKER
MLO	MAIN LUGS ONLY
(N)	NEW
P	POLES
PH	PHASE
PNL.	PANEL
PVC	POLY VINYL CHLORIDE PIPE
REF.	REFRIGERATOR
RES.	RESIDENTIAL
SWBD.	SWITCHBOARD
TYP.	TYPICAL
U.O.N.	UNLESS OTHERWISE NOTED
V	VOLTS
W	WATTS
WH	WATER HEATER
WP	WEATHERPROOF

Revisions

No.	Description	Date
1	ISSUED FOR PERMIT	04.09.08

Wine Building for:
Sorelle Winery
9593 North Highway 88
Stockton, California 95212

Sheet Title:

**Site Plan,
Symbols
& Notes**

Date: 04.09.08

Scale: AS NOTED

Project No.: 0802.06

Sheet No.:

E1.0