



1 2ND FLOOR LIGHTING PLAN
SCALE: 1/8" = 1'-0"

Sheet Notes

- ① INSTALL NEW FIXTURES UTILIZING EXISTING LIGHTING CIRCUITS. CONNECT TO NEW SWITCHES AND/OR OCCUPANCY SENSORS AS SHOWN.
- ② RE-LAMP EXISTING SURFACE MOUNTED FIXTURES WITH NEW CFL LAMPS.
- ③ MAINTAIN UNSWITCHED CIRCUIT TO EXIT SIGNS & EMERGENCY BATTERY PACKS FOR CONTINUOUS POWER TO CHARGERS.

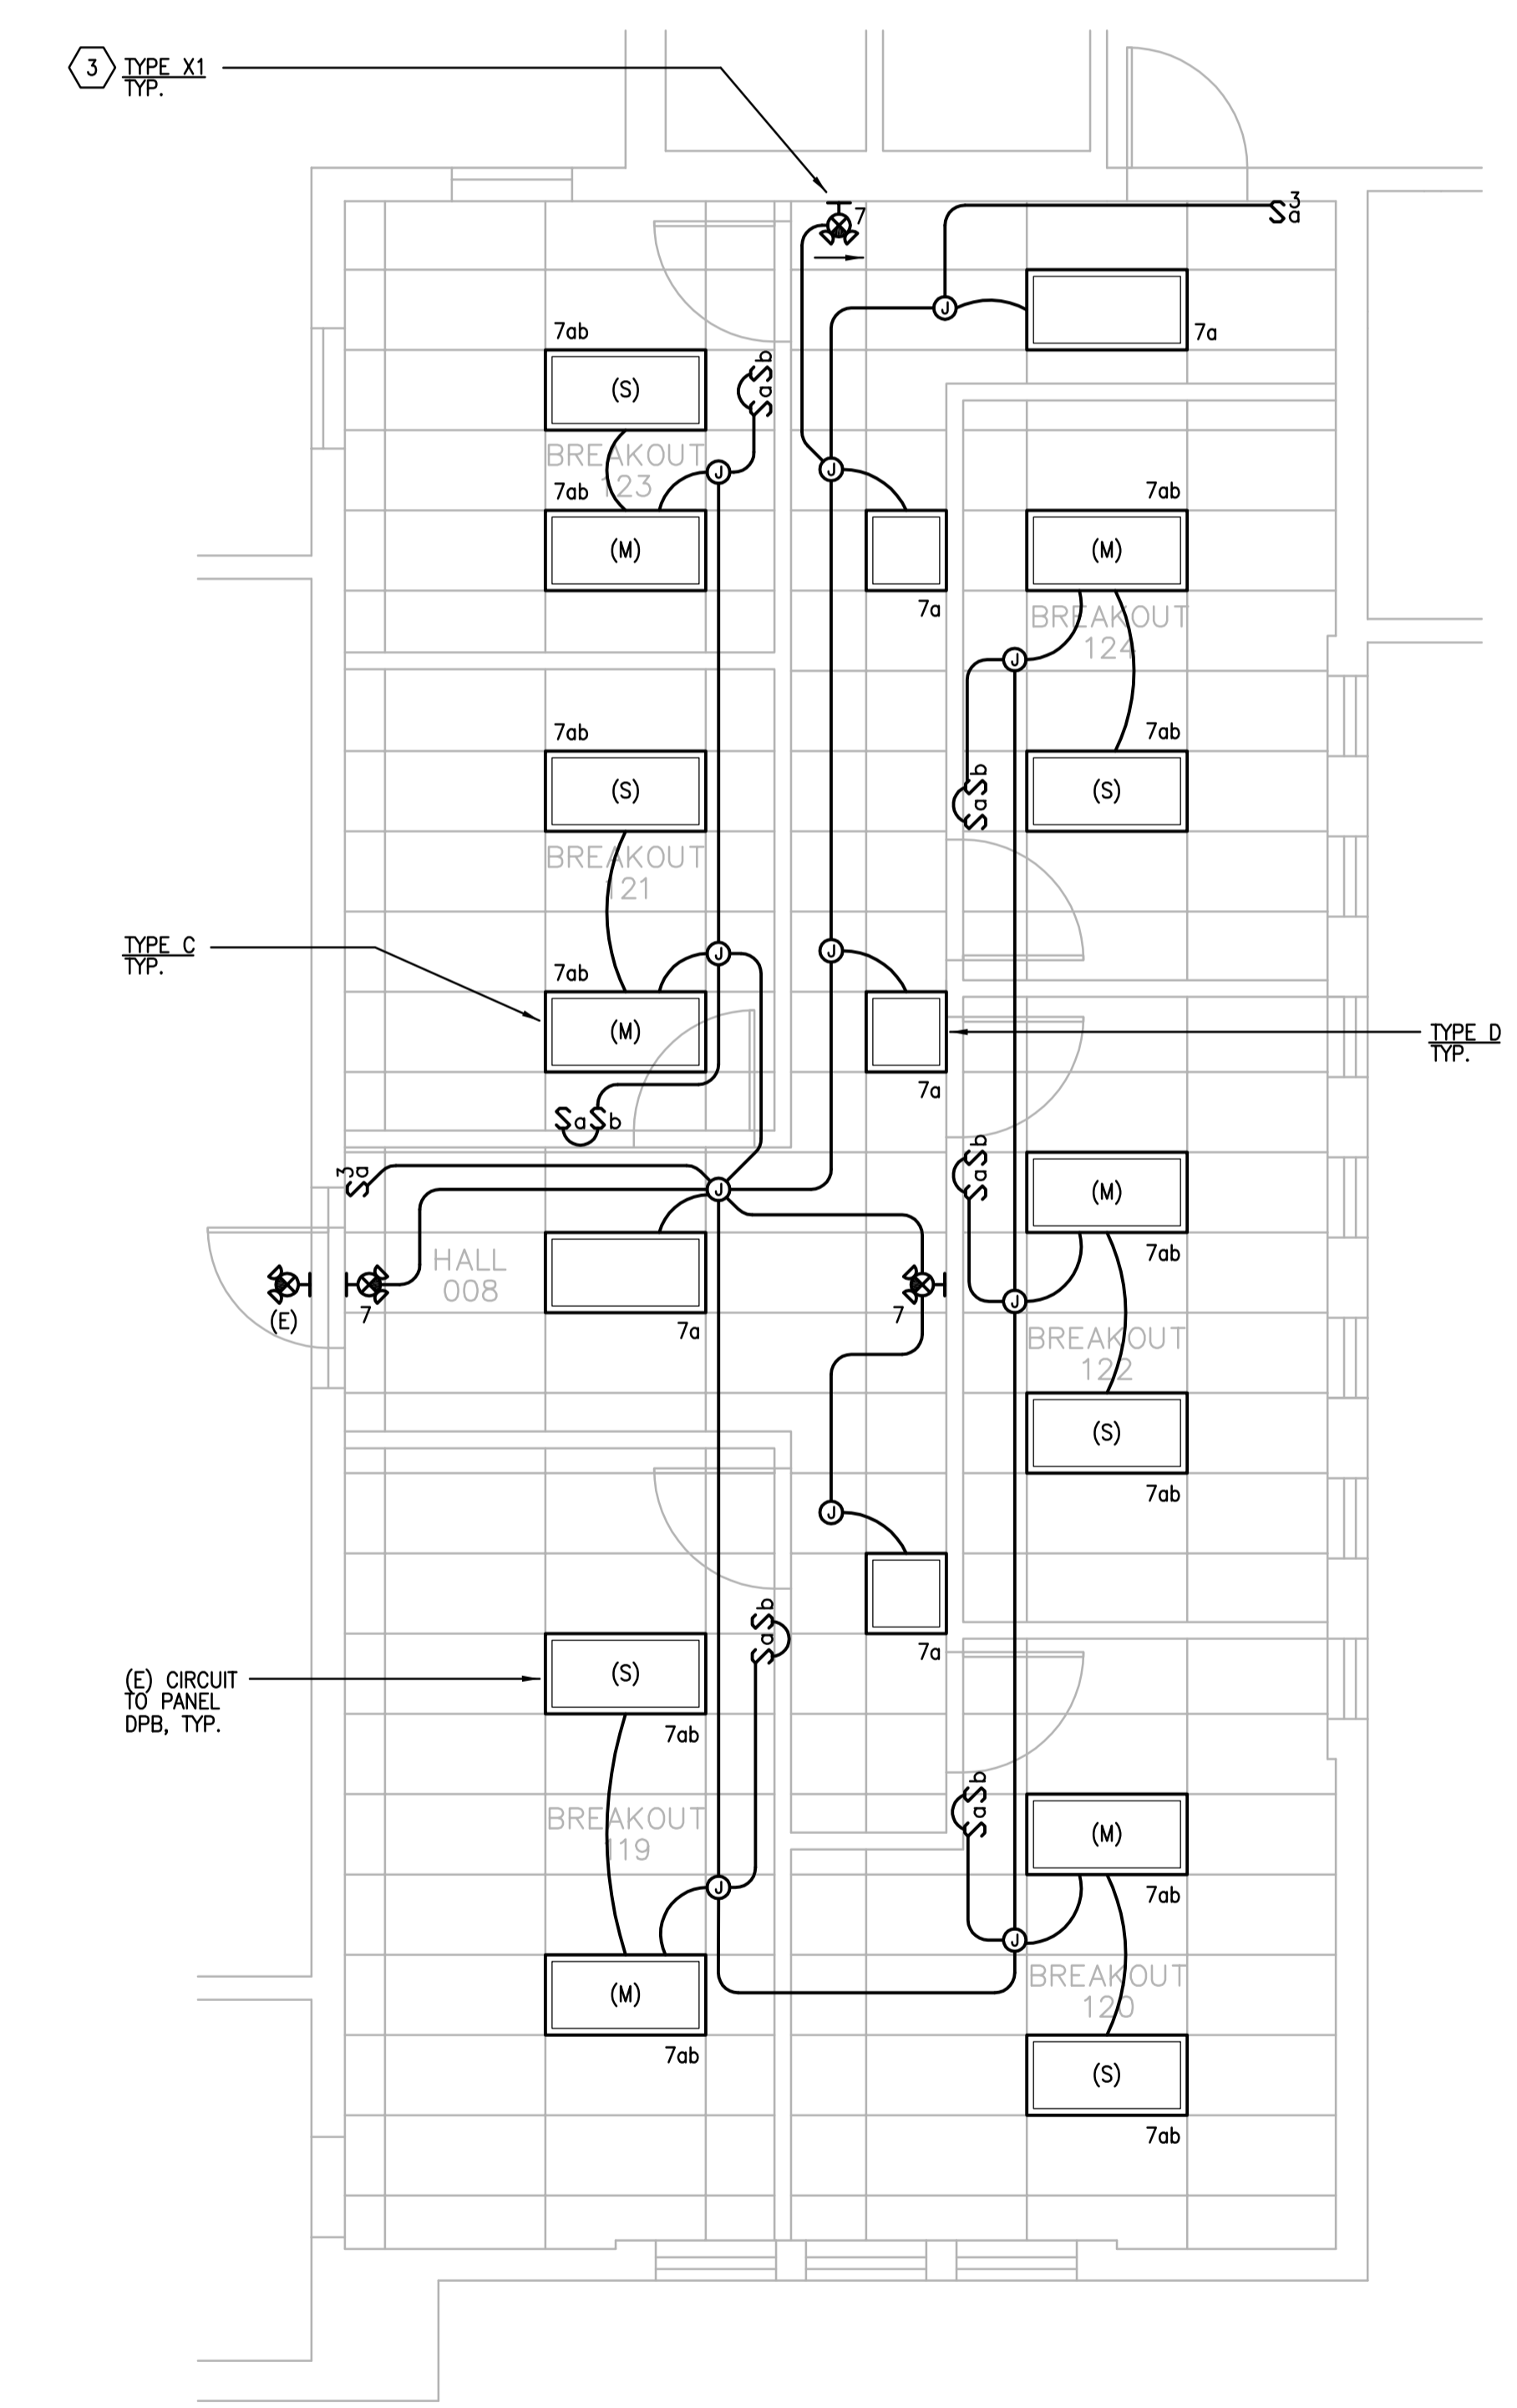

2 PARTIAL 1ST FLOOR LIGHTING PLAN
SCALE: 1/4" = 1'-0"

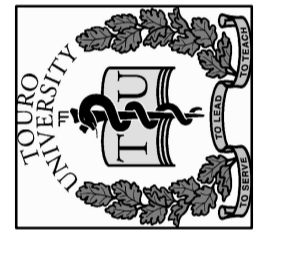

DATE: 11.14.08

REV. NO.	REV. DATE
1	FIELD REVISIONS 01.21.09

2ND FLOOR LIGHTING PLAN

E6.0

JOB NO.: TR021

© COPYRIGHT NOTICE: USE OF THESE DRAWINGS AND SPECIFICATIONS IS RESTRICTED TO THE ORIGINAL PROJECT FOR WHICH THEY WERE PREPARED. REUSE OR REPRODUCTION BY ANY MEANS, IN WHOLE OR IN PART, IS PROHIBITED. FILE IS PROVIDED AS IS. NO WARRANTY IS MADE BY THE ARCHITECT OR ENGINEER FOR THE ACCURACY OF THE INFORMATION CONTAINED HEREIN. THE ARCHITECT AND ENGINEER SHALL BE RESPONSIBLE FOR THE ACCURACY OF THE INFORMATION CONTAINED HEREIN. THE ARCHITECT AND ENGINEER SHALL BE RESPONSIBLE FOR THE ACCURACY OF THE INFORMATION CONTAINED HEREIN.