


Stamp:

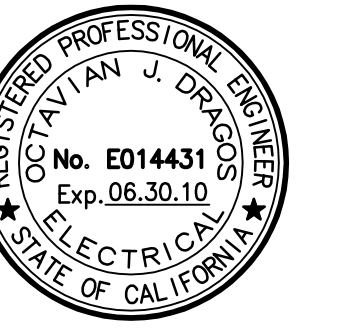

Revisions

No.	Description	Date
1	DD REVIEW	02.12.08
2	DD SUBMITTAL	03.12.08
3	50% SUBMITTAL	01.20.09
4	80% SUBMITTAL	03.16.09
5	ISSUED FOR PERMIT	04.03.09
6	REVIEW COMMENTS	06.24.09
7	REVIEW COMMENTS	07.17.09

**UNITY CENTER  
OF WALNUT CREEK**  
1871 GEARY ROAD  
WALNUT CREEK, CALIFORNIA

Sheet Title:

**New  
Lighting  
Plans**


Date: 04.06.09

Scale: AS NOTED

Project No.: 0708.02


Sheet No.:

**E4.0**

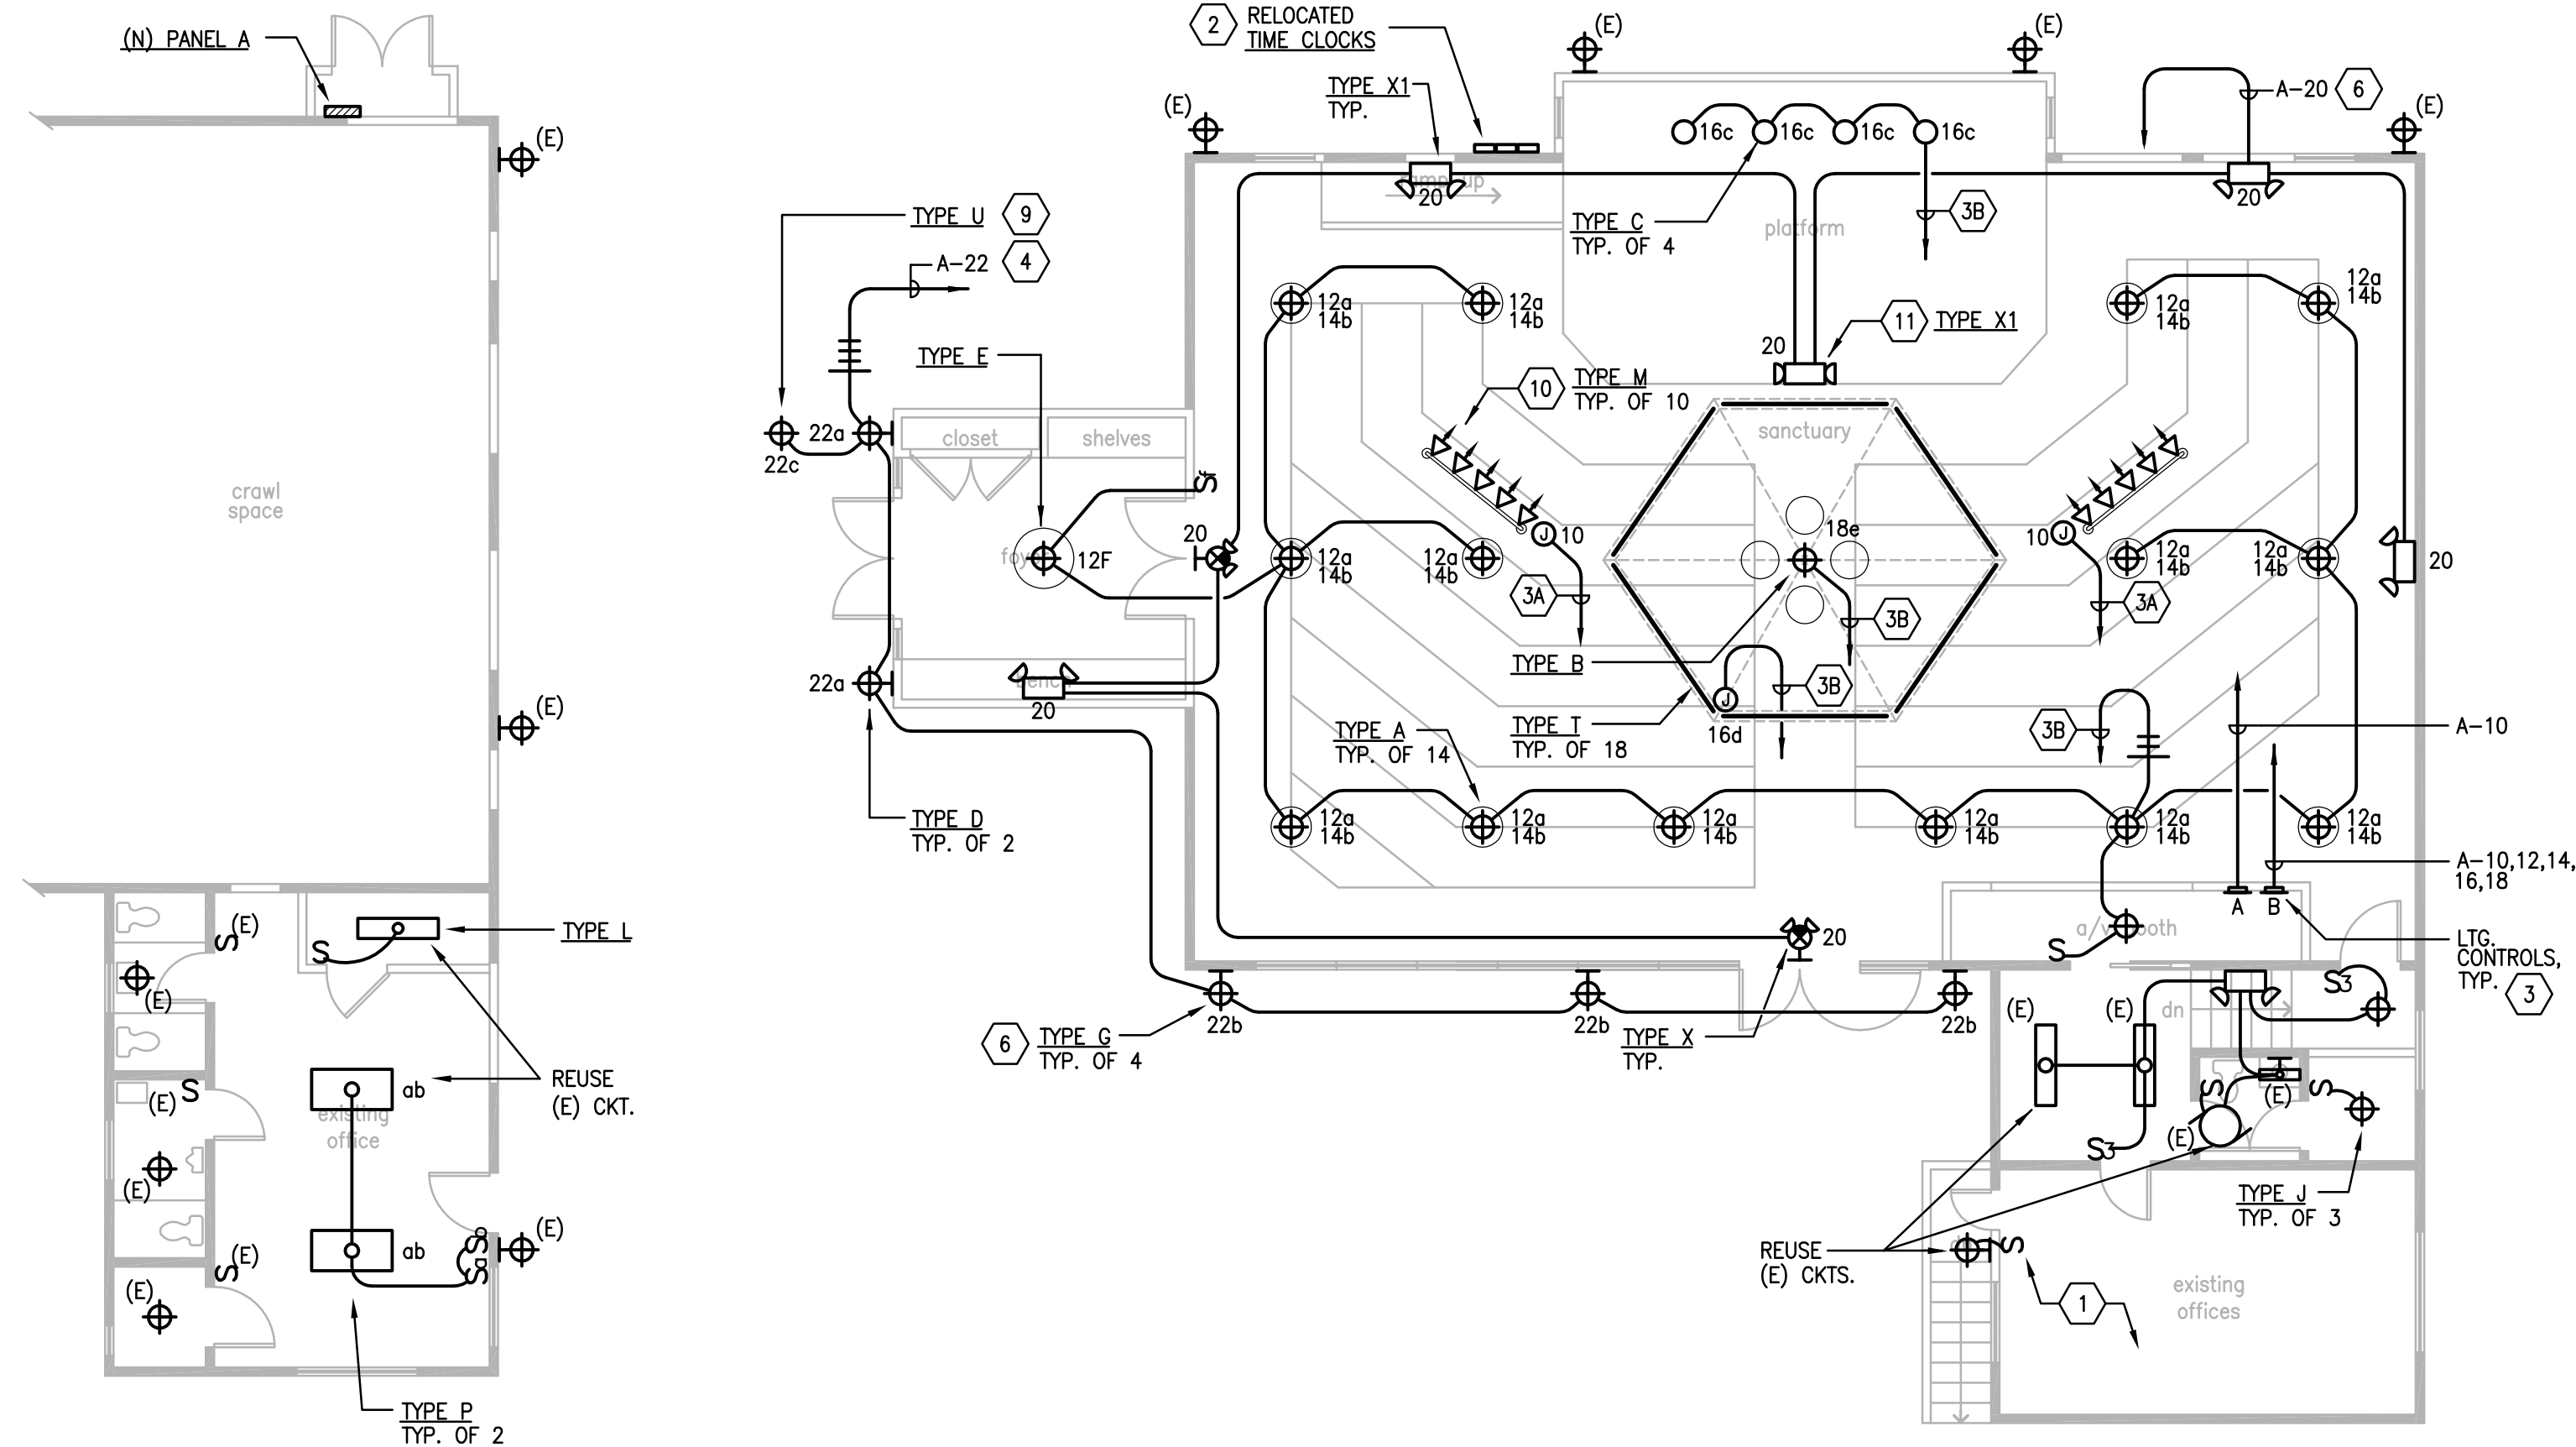


**1** NEW LIGHTING PLAN  
LOWER LEVEL SANCTUARY  
SCALE: 1/8" = 1'-0"

**2** NEW LIGHTING PLAN  
MAIN LEVEL SANCTUARY  
SCALE: 1/8" = 1'-0"

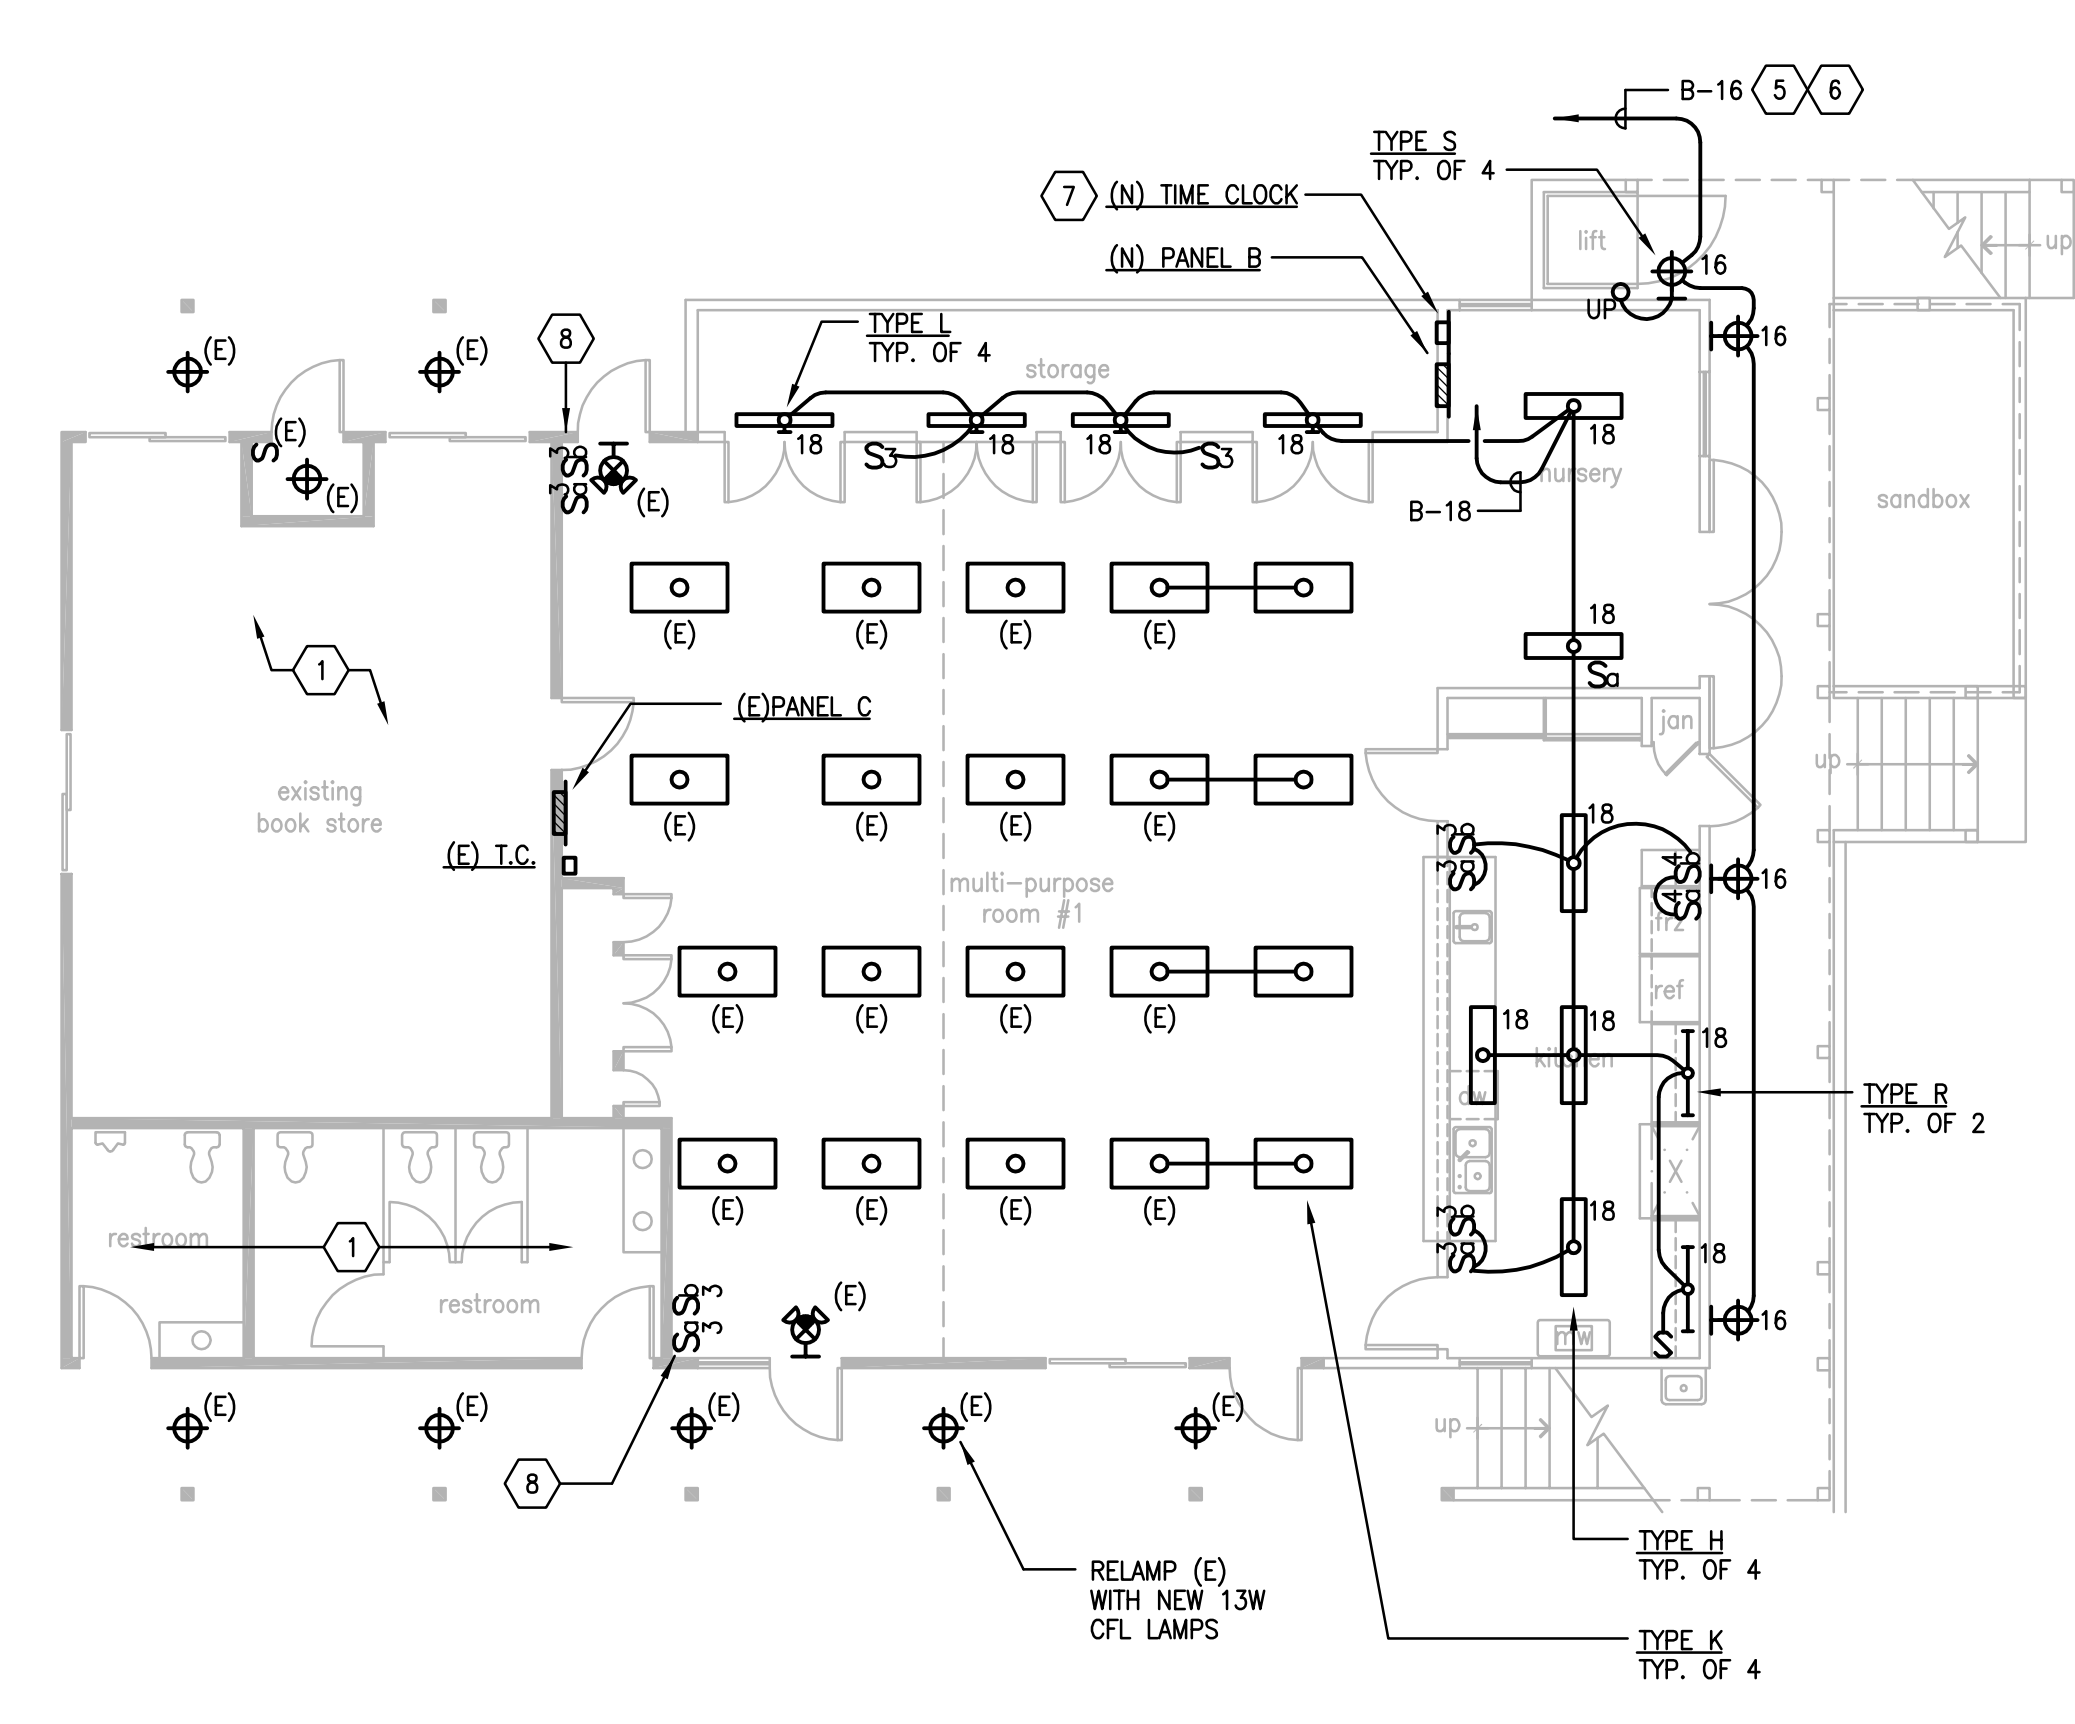

**3** NEW LIGHTING PLAN  
1ST FLOOR YOUTH EDUCATION BUILDING  
SCALE: 1/8" = 1'-0"

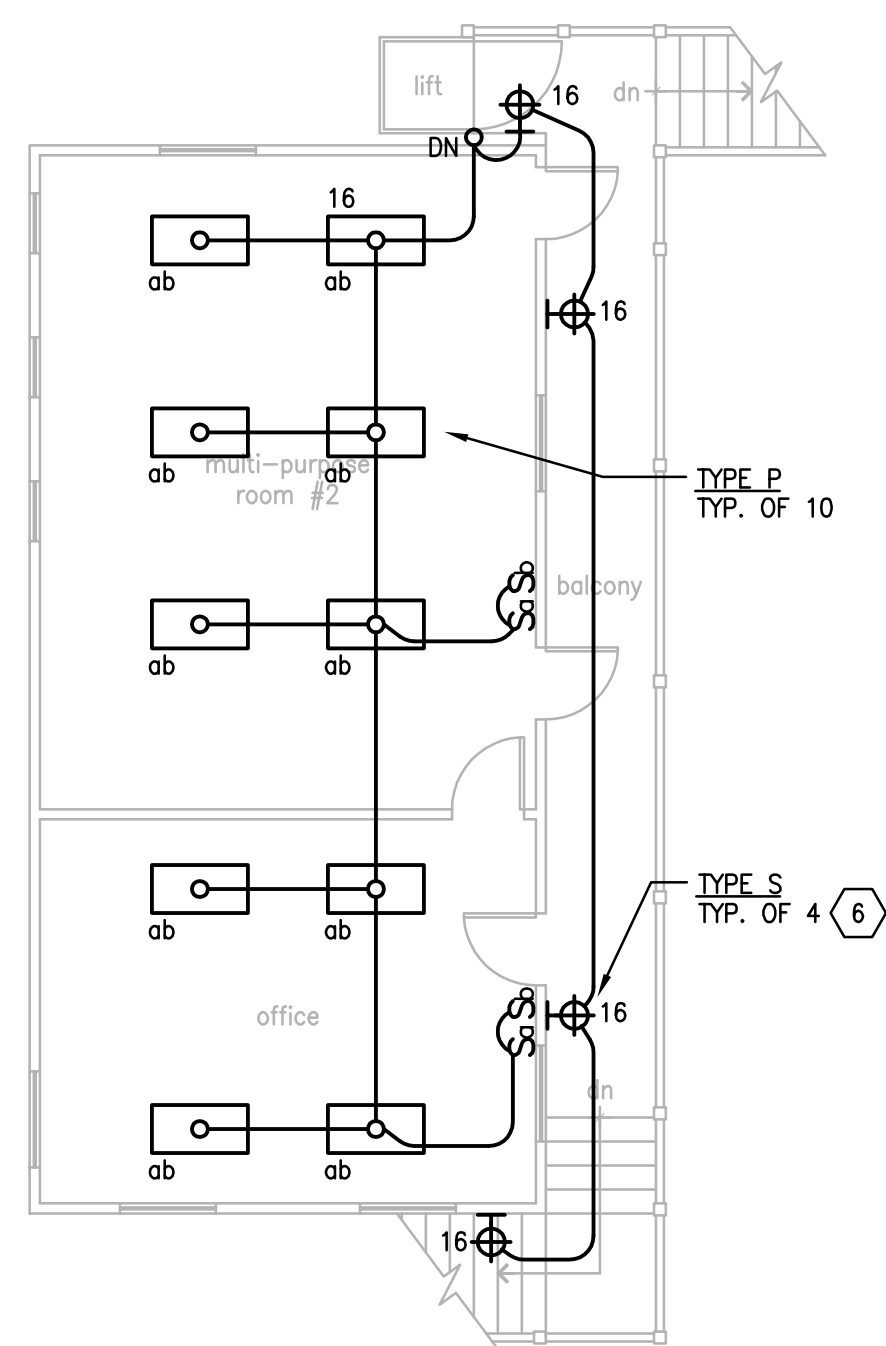

**4** NEW LIGHTING PLAN  
2ND FLOOR YOUTH EDUCATION BLDG.  
SCALE: 1/8" = 1'-0"

**SHEET NOTES**

- 1 EXISTING LIGHT FIXTURES & CONTROLS IN THESE AREAS TO REMAIN AS-IS.
- 2 EXISTING TIME CLOCKS MOUNTED IN NEW LOCATION.
- 3 PROVIDE & INSTALL LIGHTING CONTROLS AS FOLLOWS:
 

STATION	DESCRIPTION
A	(5) LUTRON MAESTRO DIMMERS TO CONTROL THEATRICAL SPOTS TYPE M
B	(5) LUTRON MAESTRO DIMMERS TO CONTROL FIXTURES TYPE A, B, C & T.
- 4 ROUTE CIRCUITS VIA (E) TIME CLOCK.
- 5 ROUTE CIRCUITS VIA NEW TIME CLOCK.
- 6 MAINTAIN UNSWITCHED HOT TO FIXTURES WITH INTEGRAL EM BATTERY PACKS/CHARGERS.
- 7 PROVIDE & INSTALL NEW TIME CLOCK TO CONTROL EXTERIOR TYPE S FIXTURES.
- 8 RE-WIRE (E) FIXTURES IN MULTI-PURPOSE ROOM & INSTALL NEW 3-WAY SWITCHES AS SHOWN TO CONTROL ALTERNATING ROWS OF FIXTURES.
- 9 TYPE U FIXTURE TO BE MOUNTED CONCEALED UNDER ROOF EAVE & BE AIMED TO ILLUMINATE RELOCATED BUILDING ADDRESS NUMBERS; SEE ARCHITECTURAL ELEVATIONS FOR LOCATION.
- 10 COORDINATE EXACT LOCATION OF THEATRICAL FIXTURES WITH OWNER PRIOR TO INSTALLATION.
- 11 FIXTURE TYPE SIMILAR TO TYPE X1 EXCEPT FLUSH MOUNTED IN CEILING.